


24-26 September 2024

Riyadh International Convention and Exhibition Center - (RICEC)

Global Water Expo

Global Water Expo

Saudi Infrastructure Expo

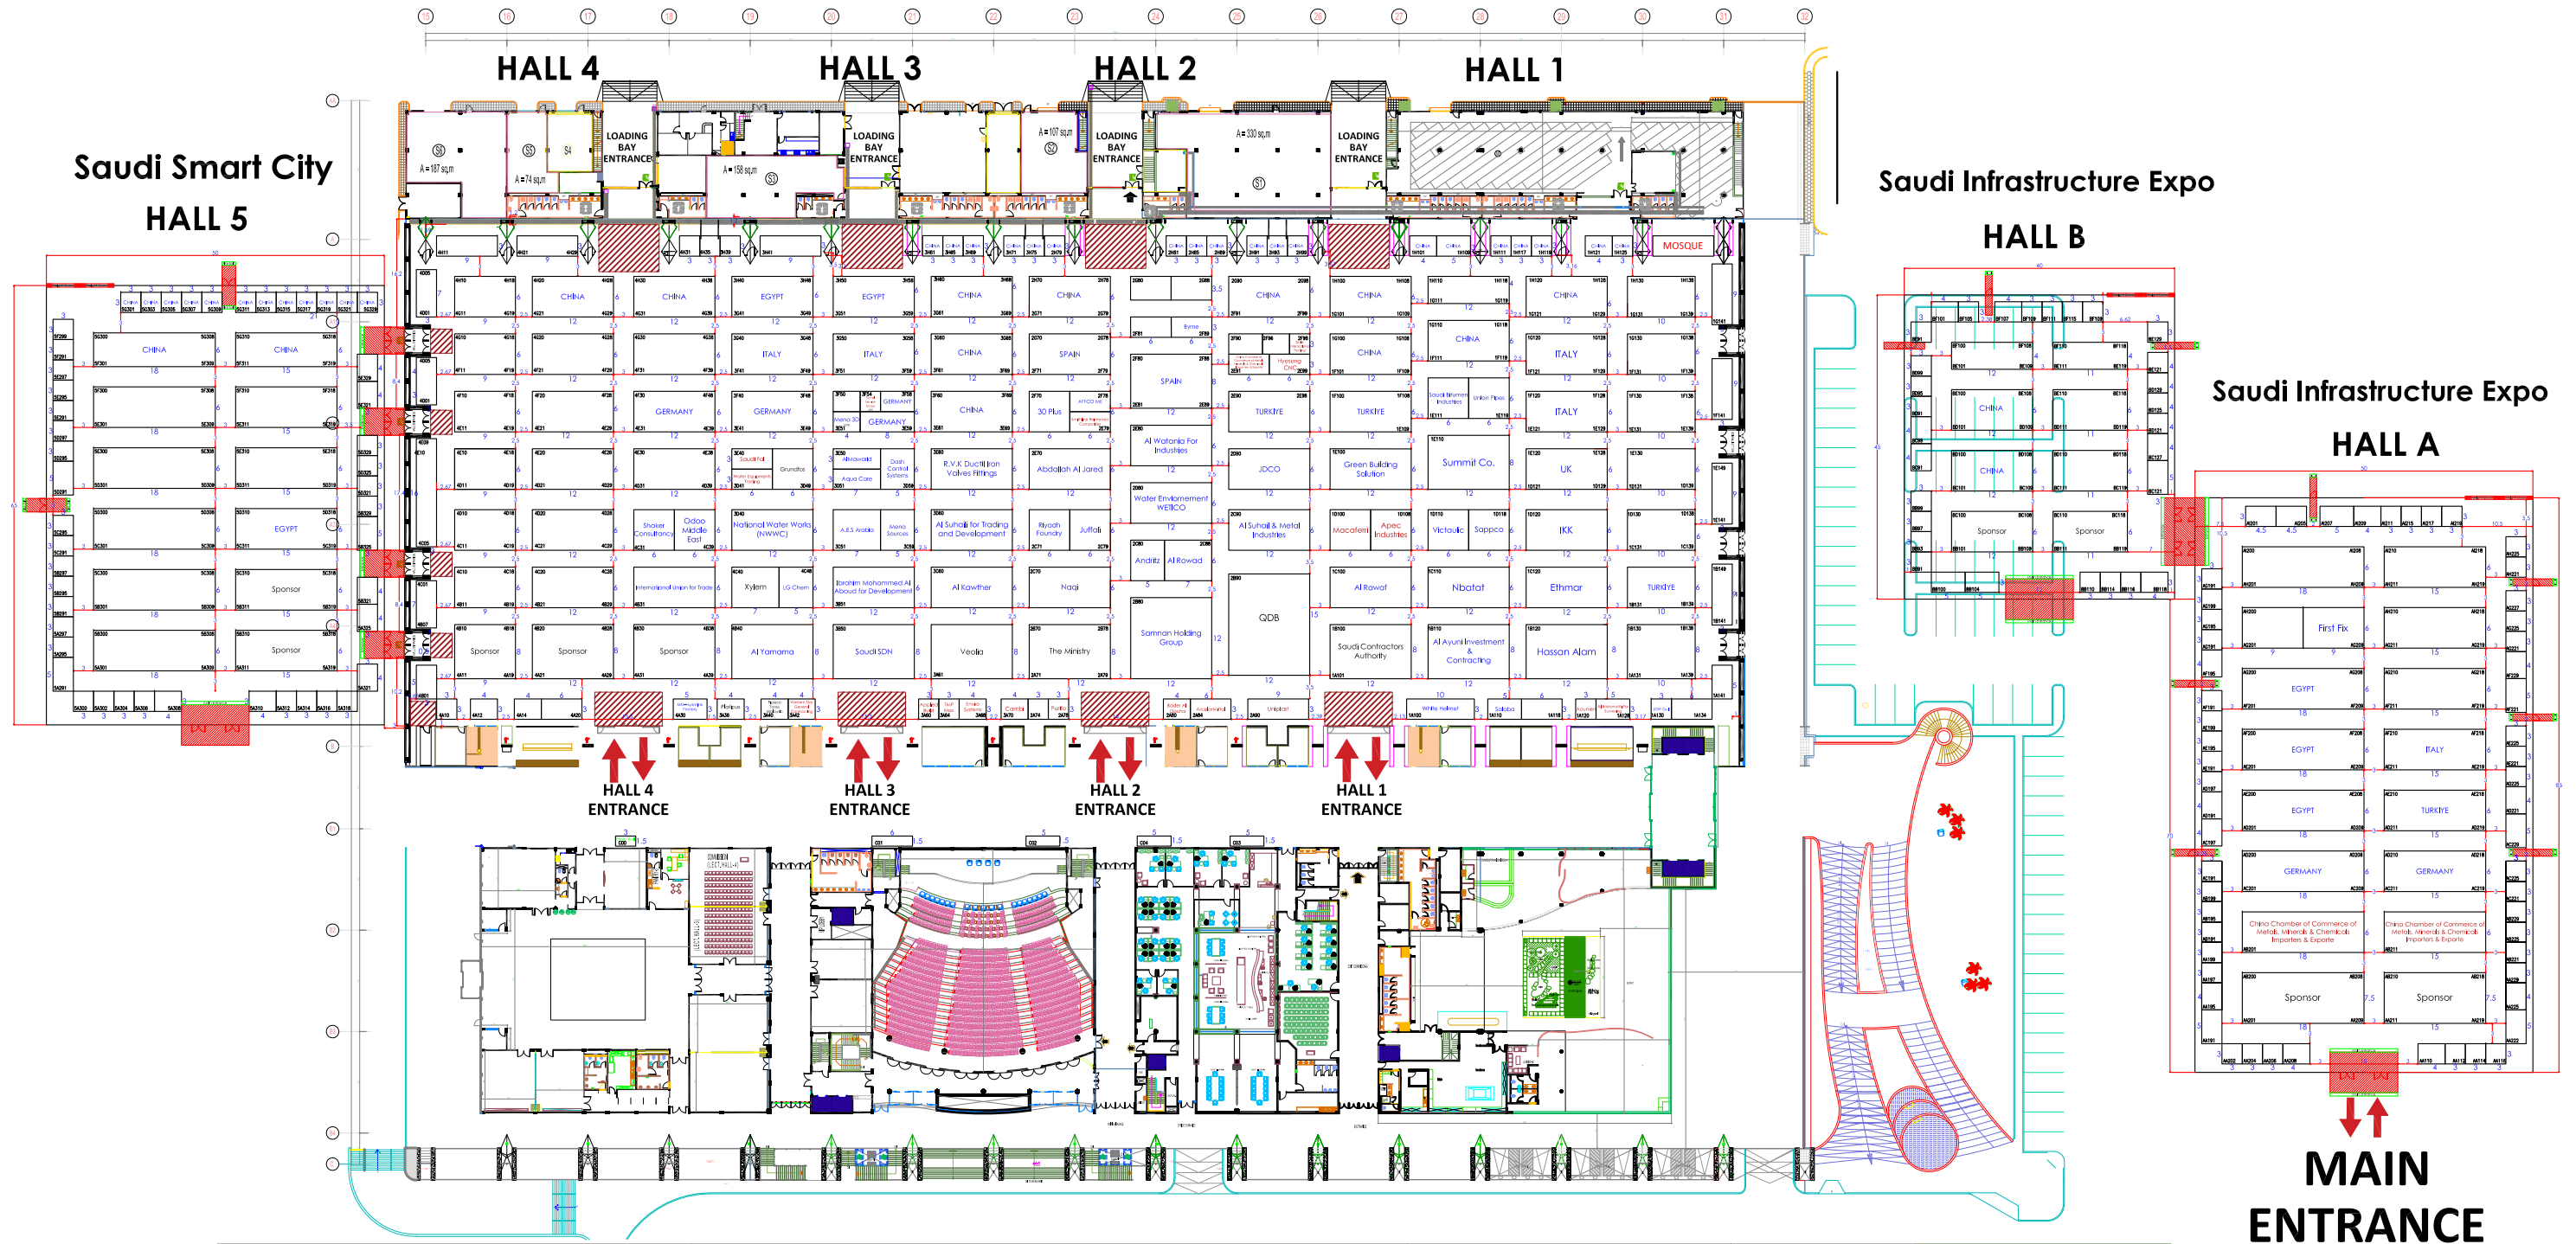

الغرفة التجارية والصناعية بالرياض
RIYADH CHAMBER OF COMMERCE AND INDUSTRY

DWG. TITLE:
GROUND FLOOR PLAN
SCALE: - 1:700

FACILITY:
MAIN BLDG.

C:\Users\mahFoz\Desktop\RICEC_logo.jpg